

Rock Creek

Drawn By: RS
 Checked By:
 Date: 10/25/2023

Scale:

#	Date	Comments

Luminaire Schedule			
Symbol	Qty	Label	Tag
	45	LED-ARL3 150W T3	W1
	17	LED-ARL2-300W-T4	P1

Calculation Summary		
Label	Avg	Units
Site Calculation Points	0.94	Fc

Comments

Date

#

Revisions


Drawn By: RS

Checked By:

Date: 10/25/2023

Scale:

Rock Creek

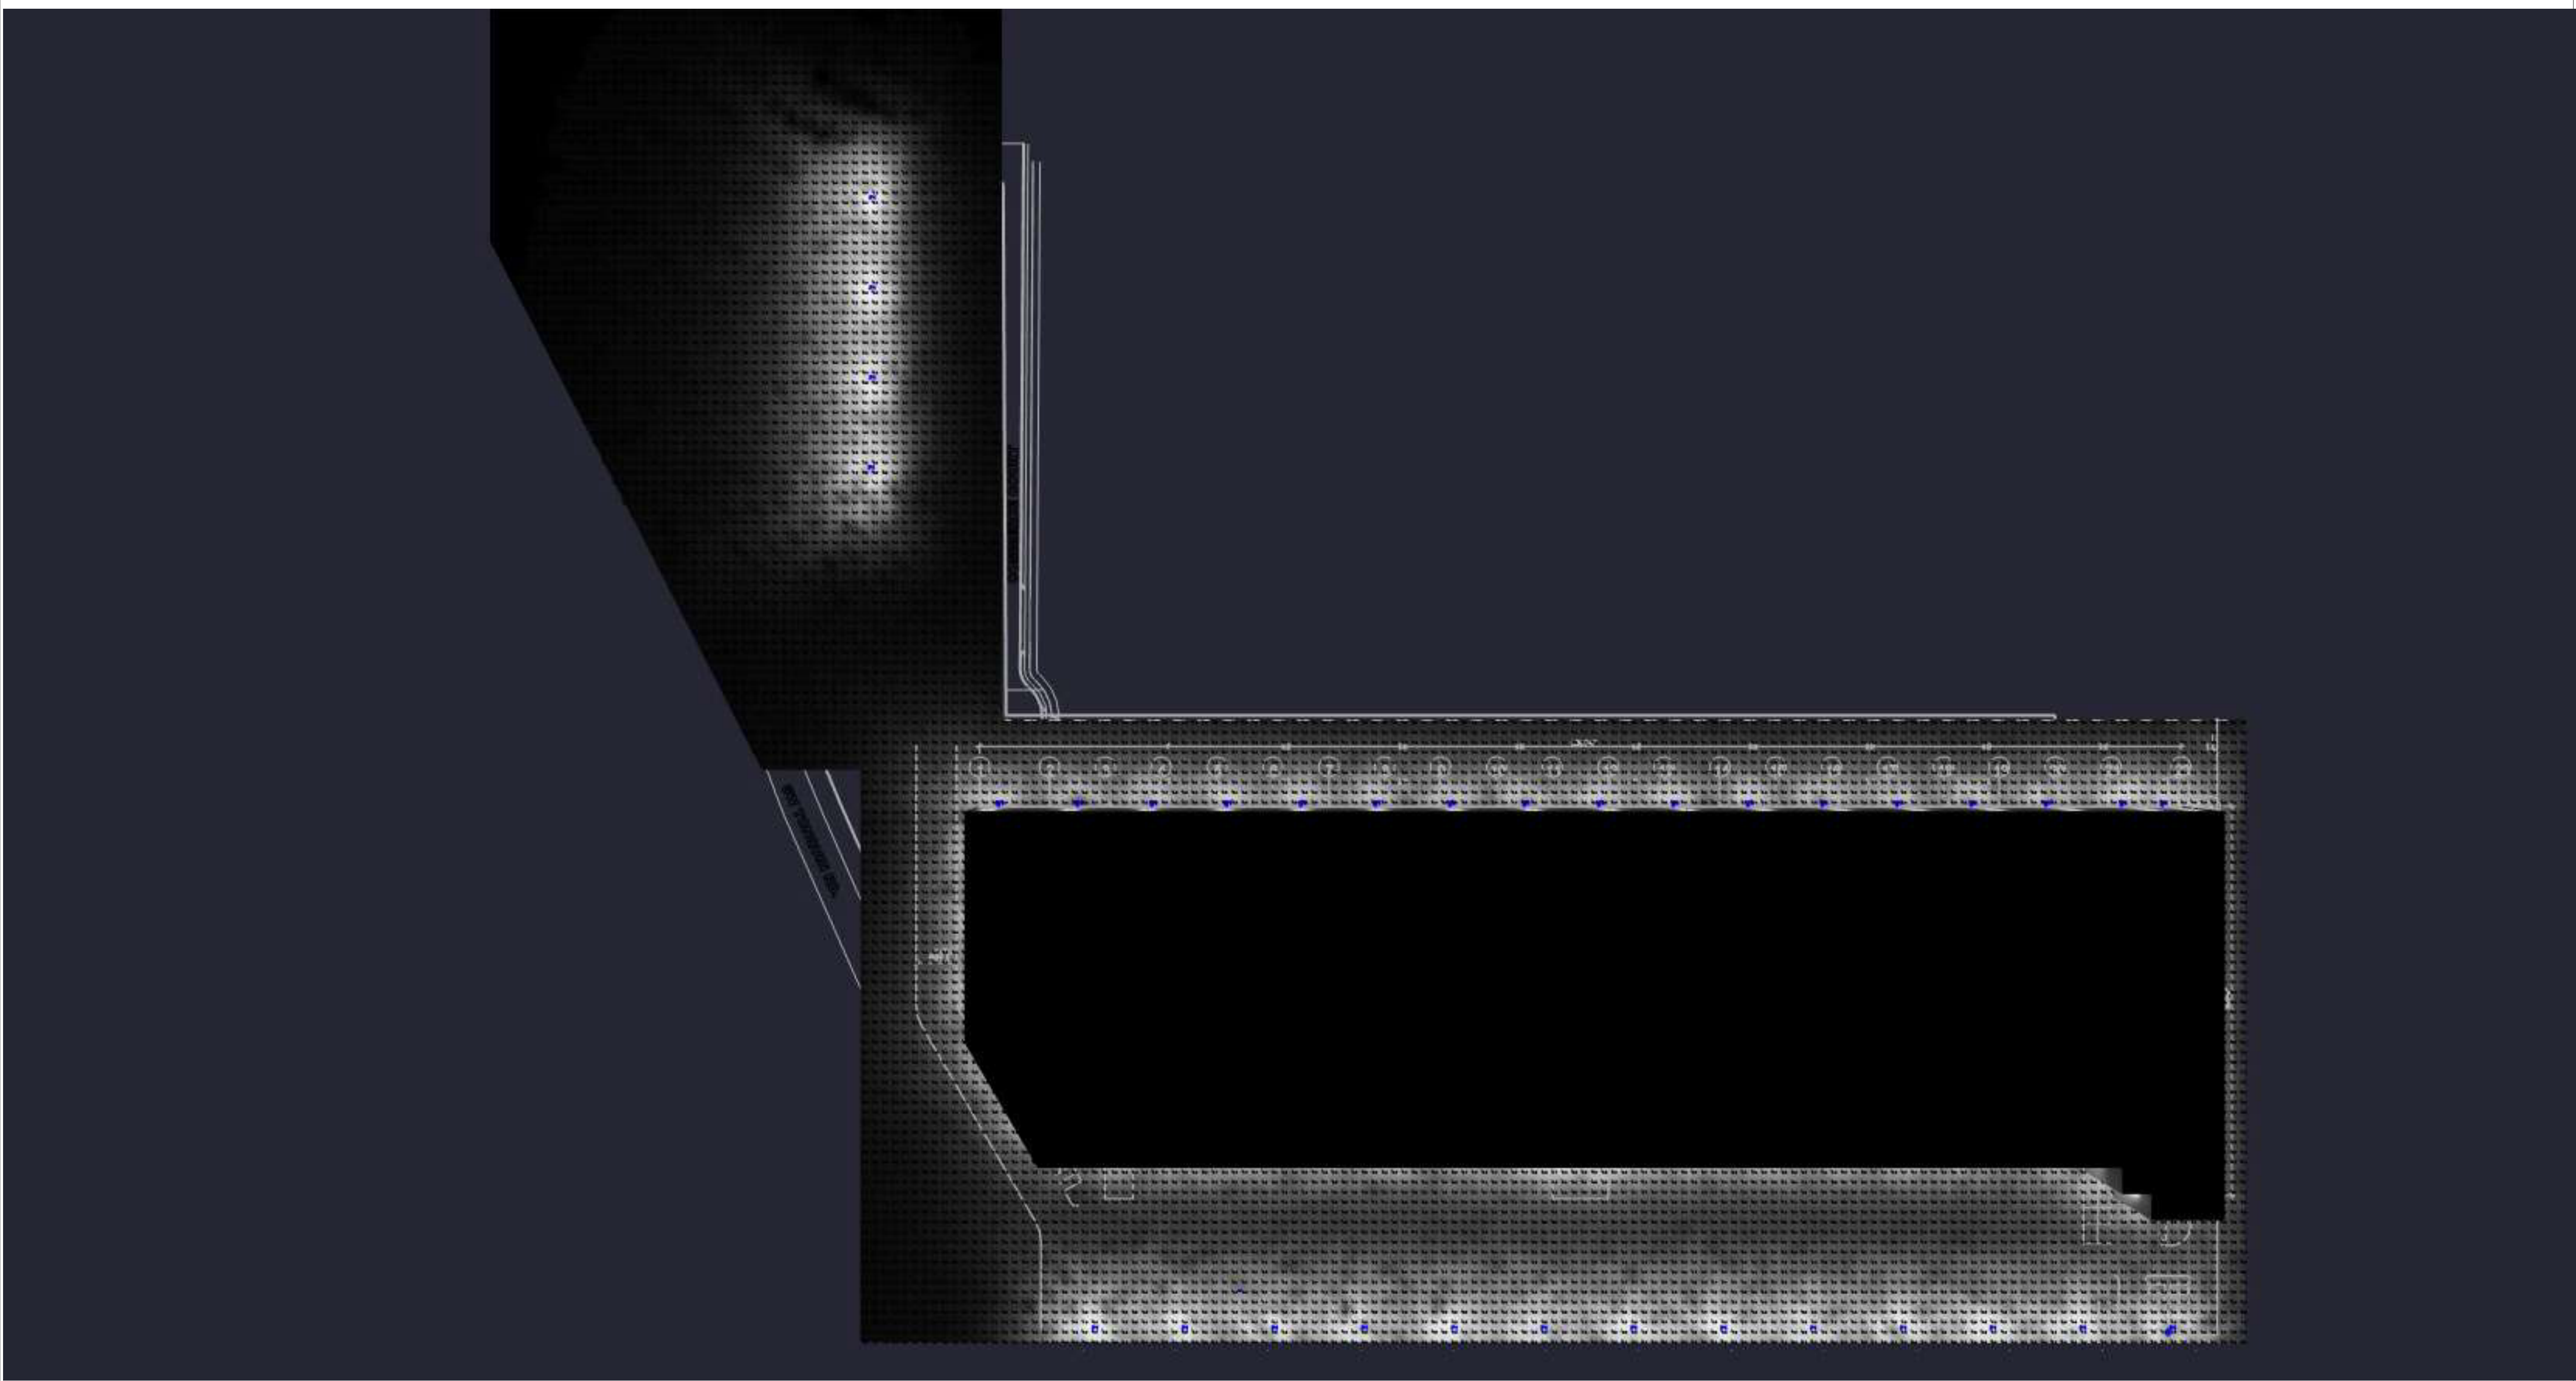


Rock Creek

Drawn By: RS
Checked By:
Date: 10/25/2023
Scale:

#	Date	Comments

Revisions

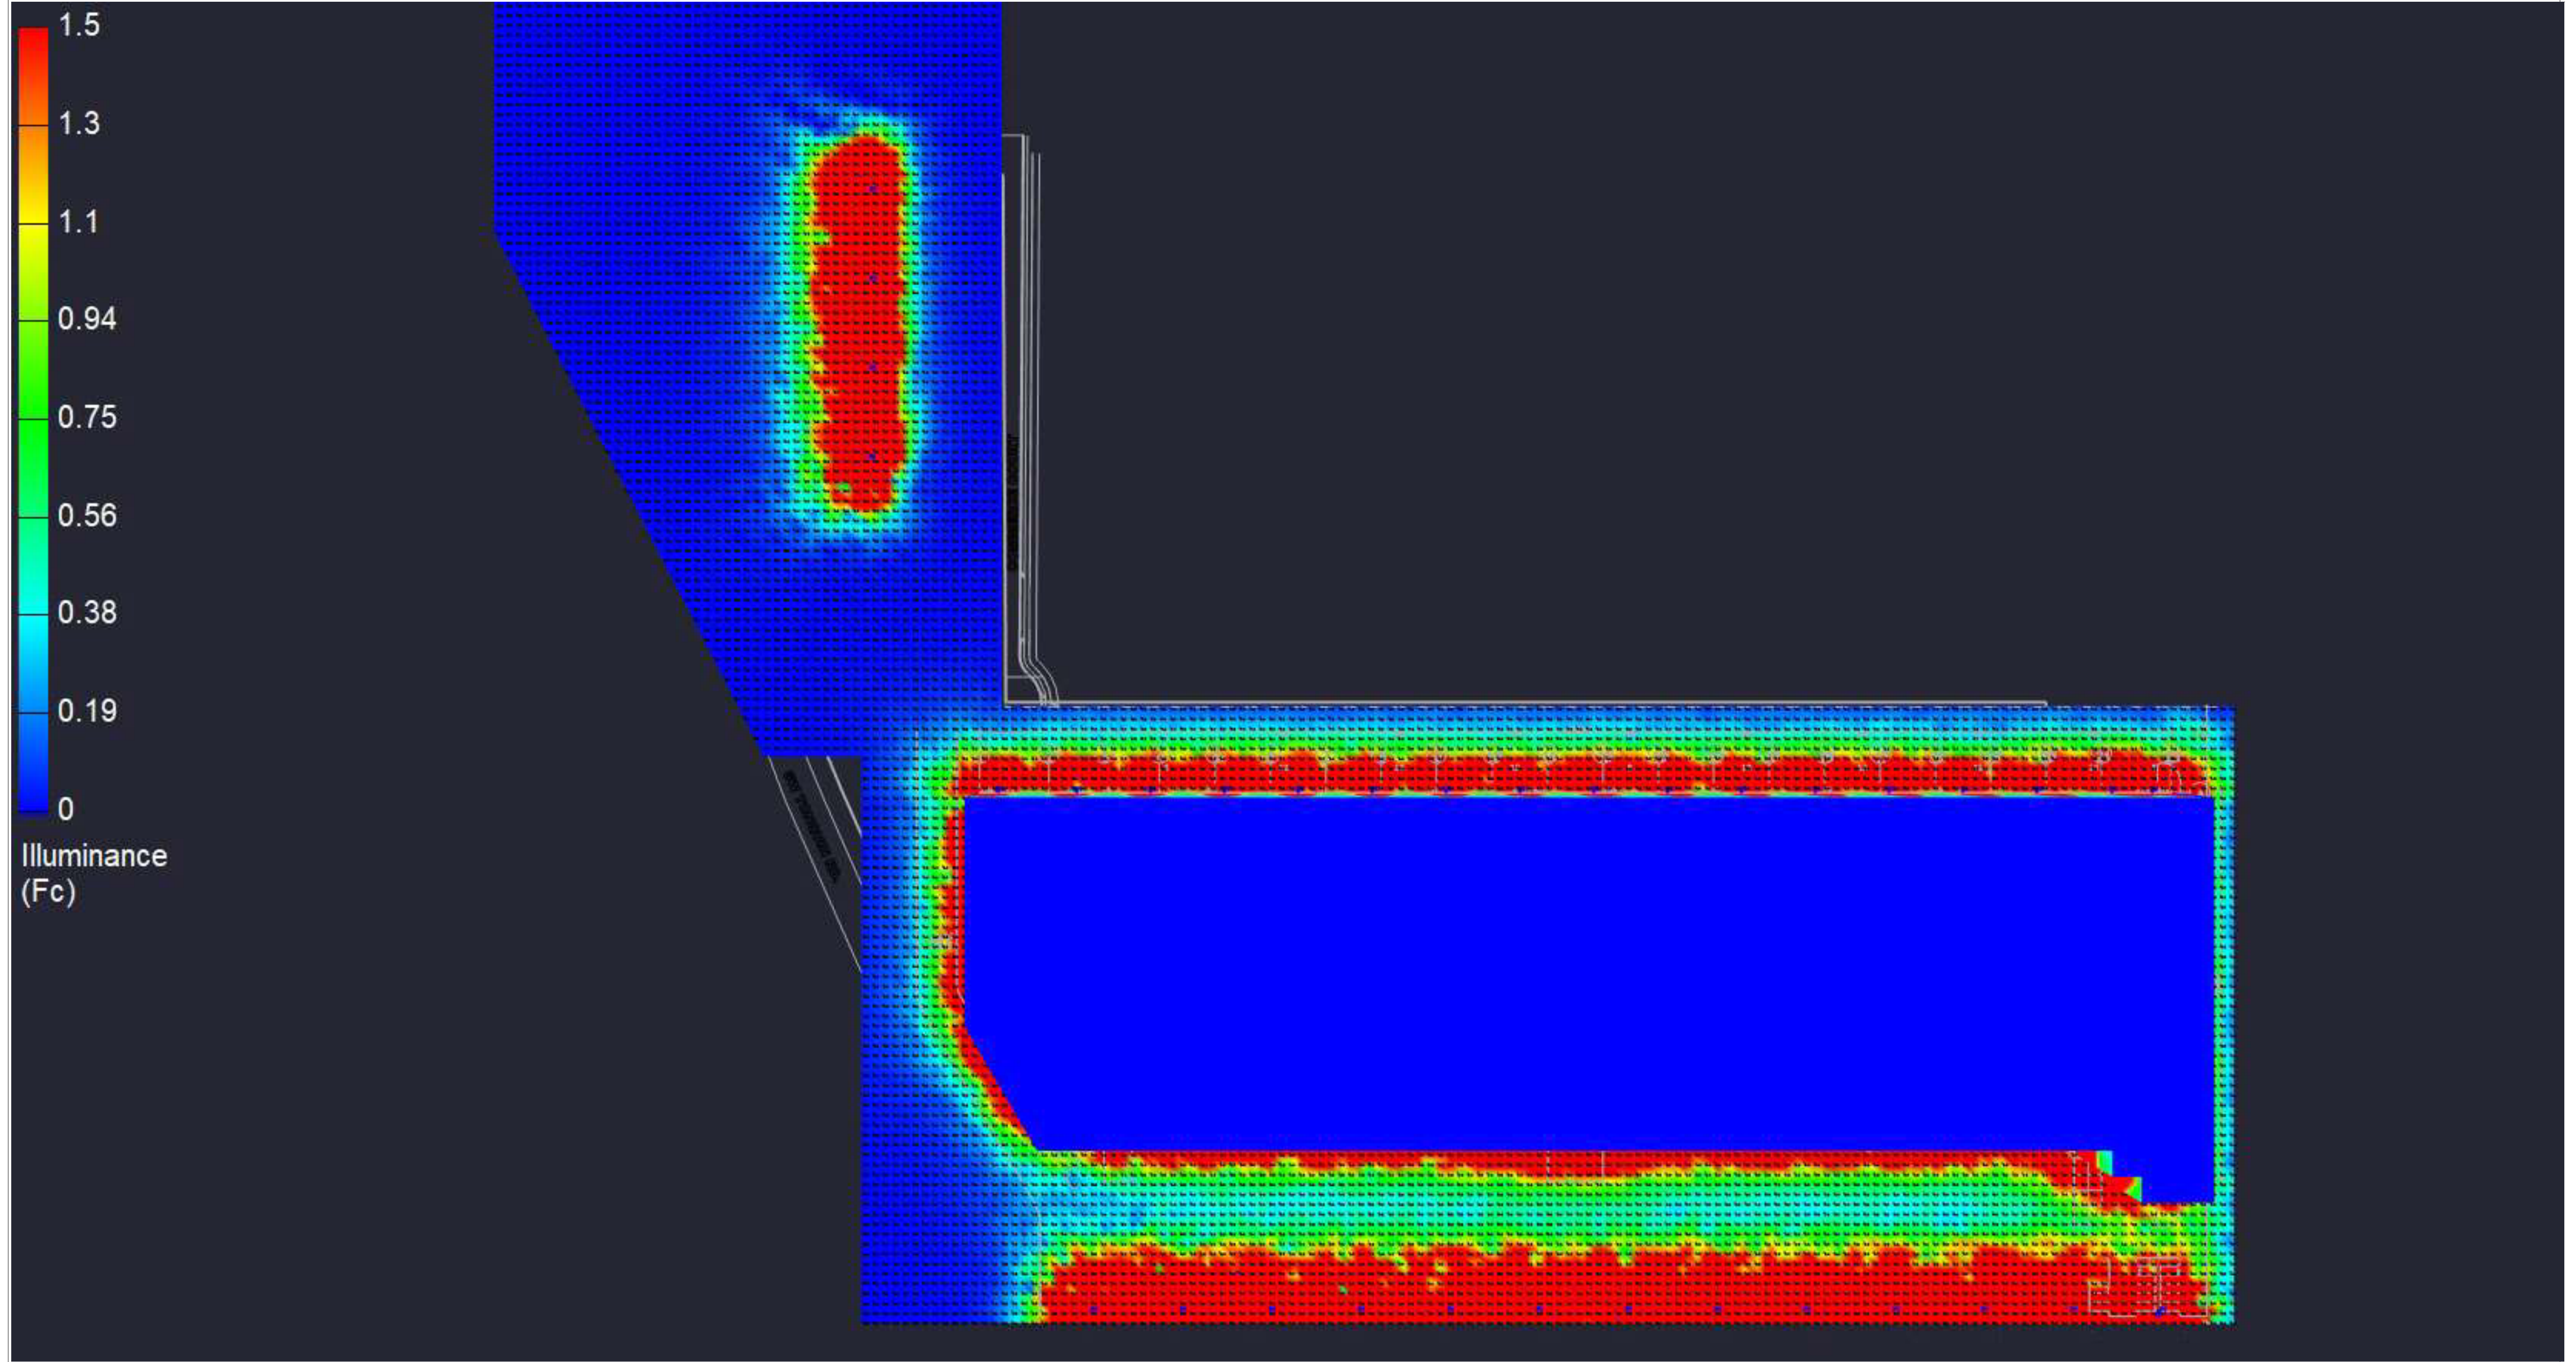

#	Date	Comments

Revisions

Drawn By: RS
 Checked By:
 Date: 10/25/2023
 Scale:

Rock Creek